

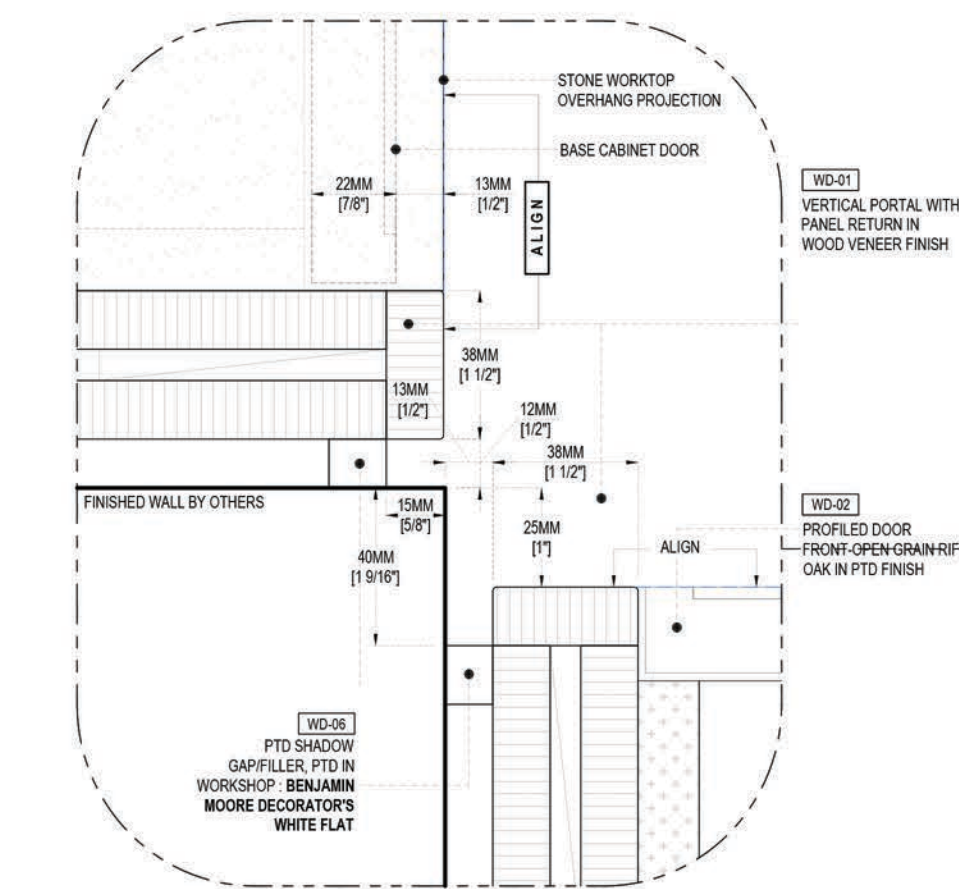


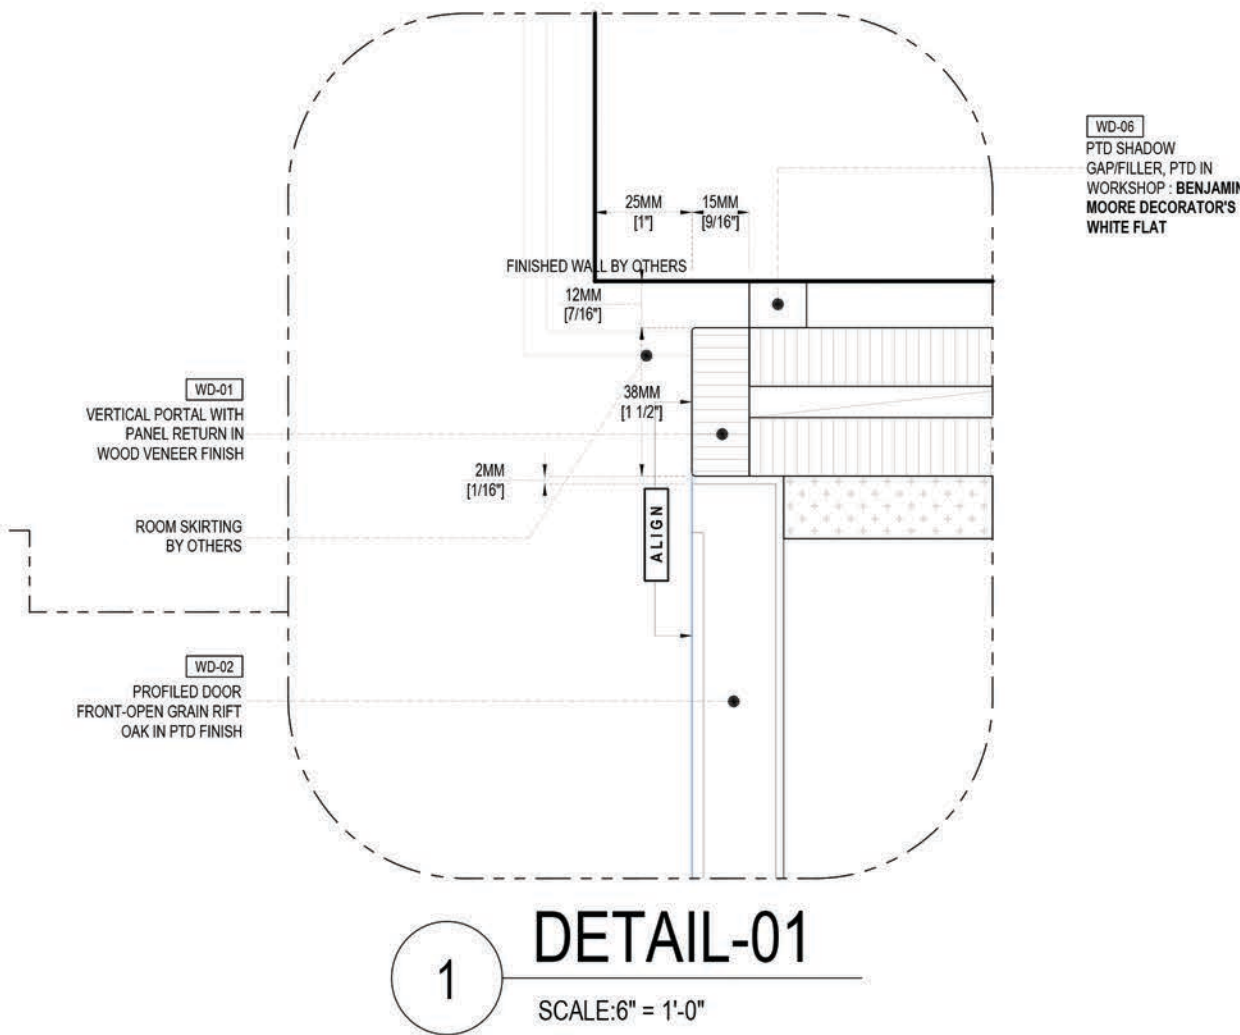

2
SCALE: 6" = 1'-0"





APARTMENT	FLOOR	QTY	FINISH SCHEME
C	02-14	13	LIGHT SCHEME



NOTE: DARK SCHEME AVAILABLE BY PURCHASER REQUEST ONLY

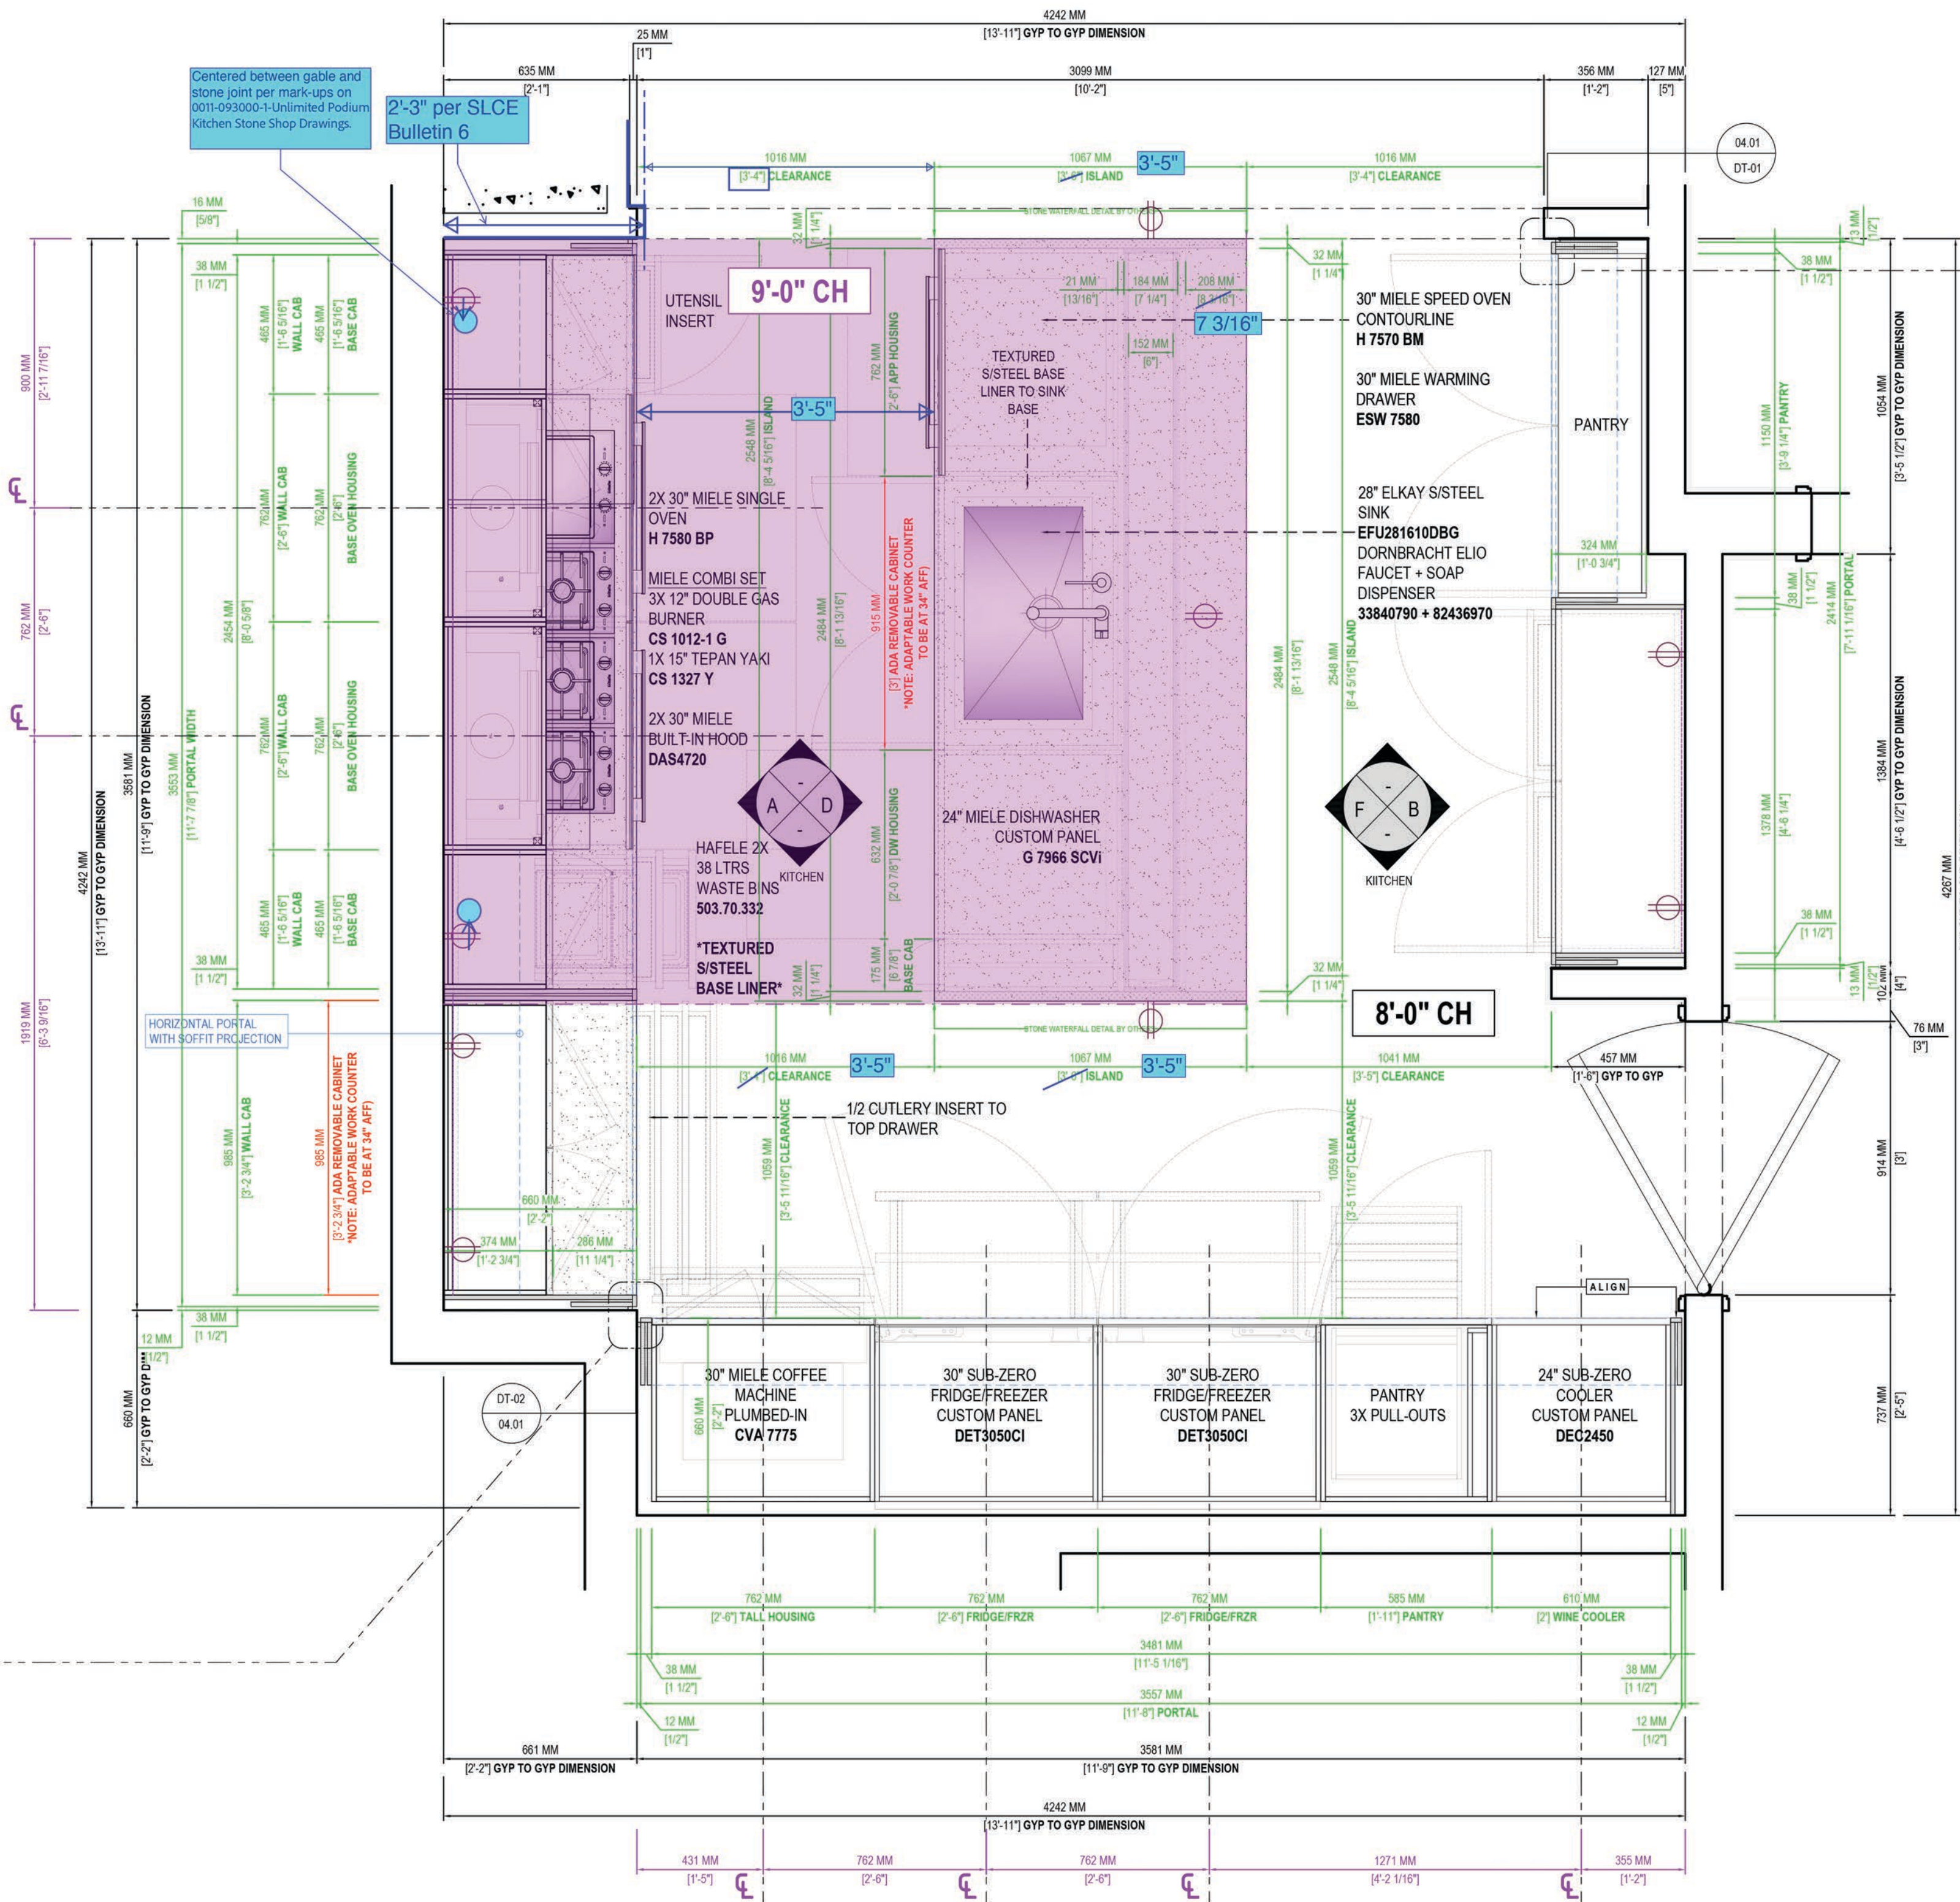

1
SCALE: 6" = 1'-0"

(1) ONE OF THESE LAYOUTS
NO CABINET HANDLES
NO APPLIANCES
NO PLUMBING FIXTURES

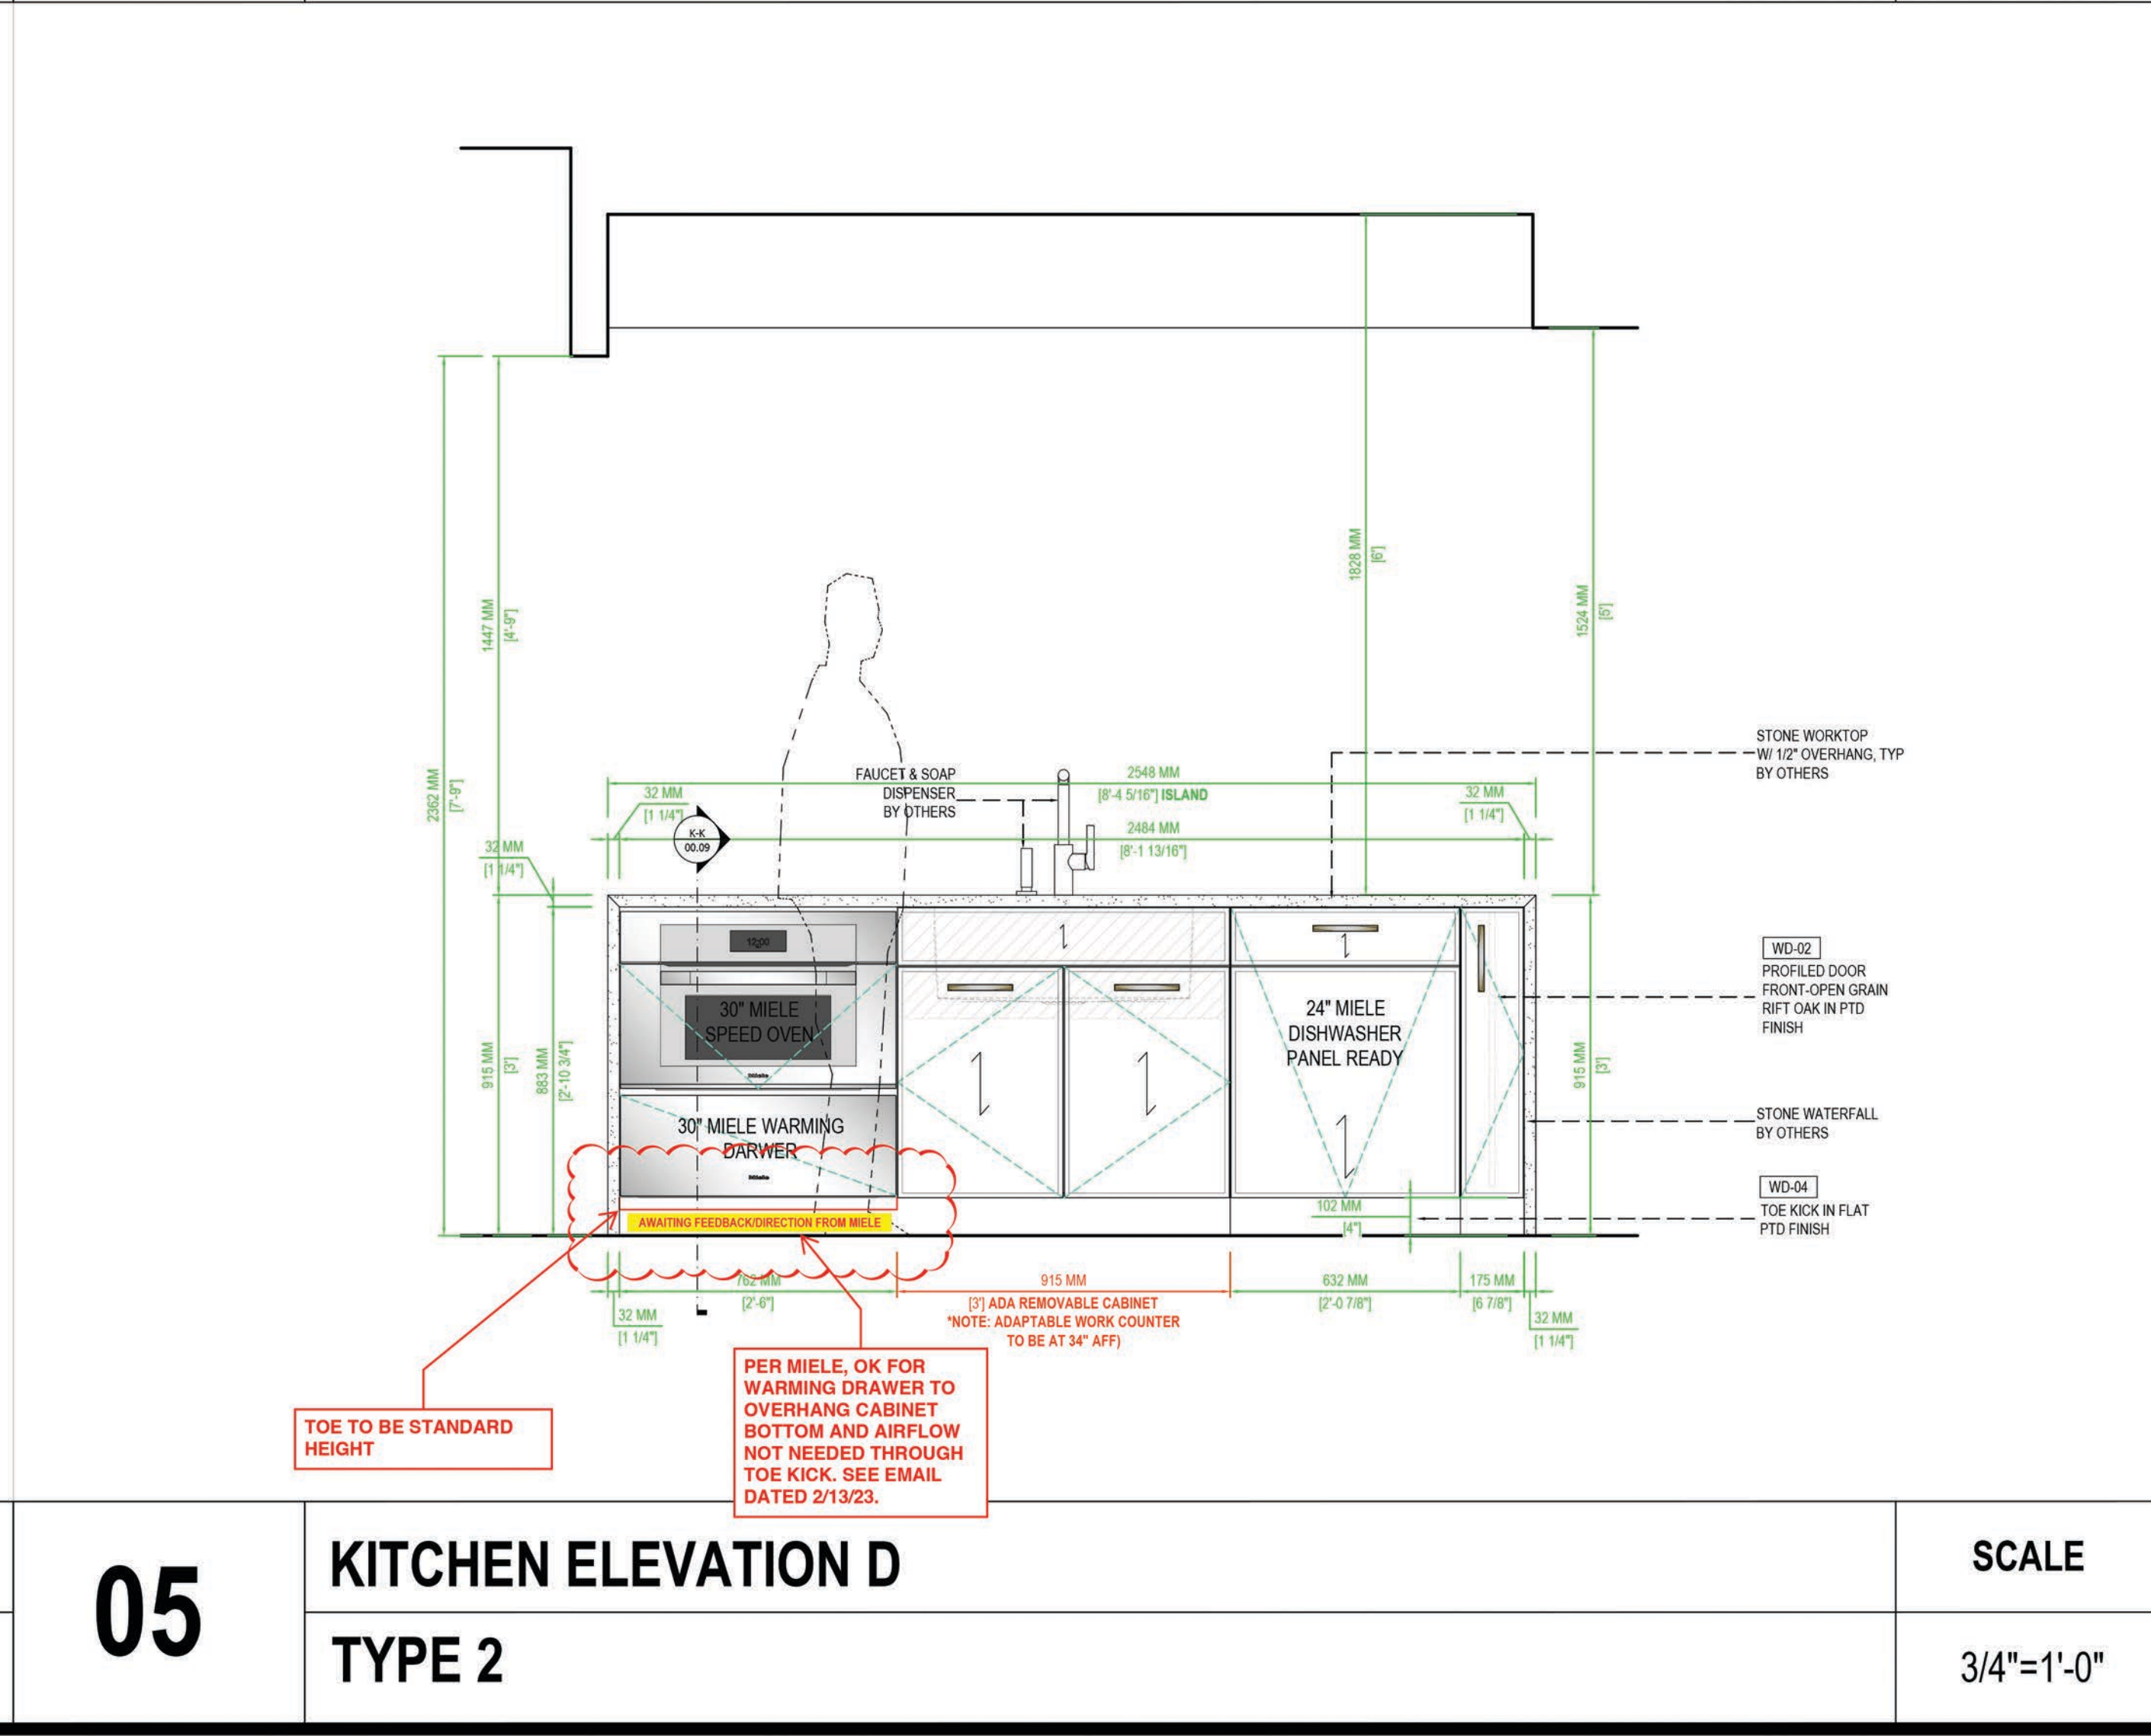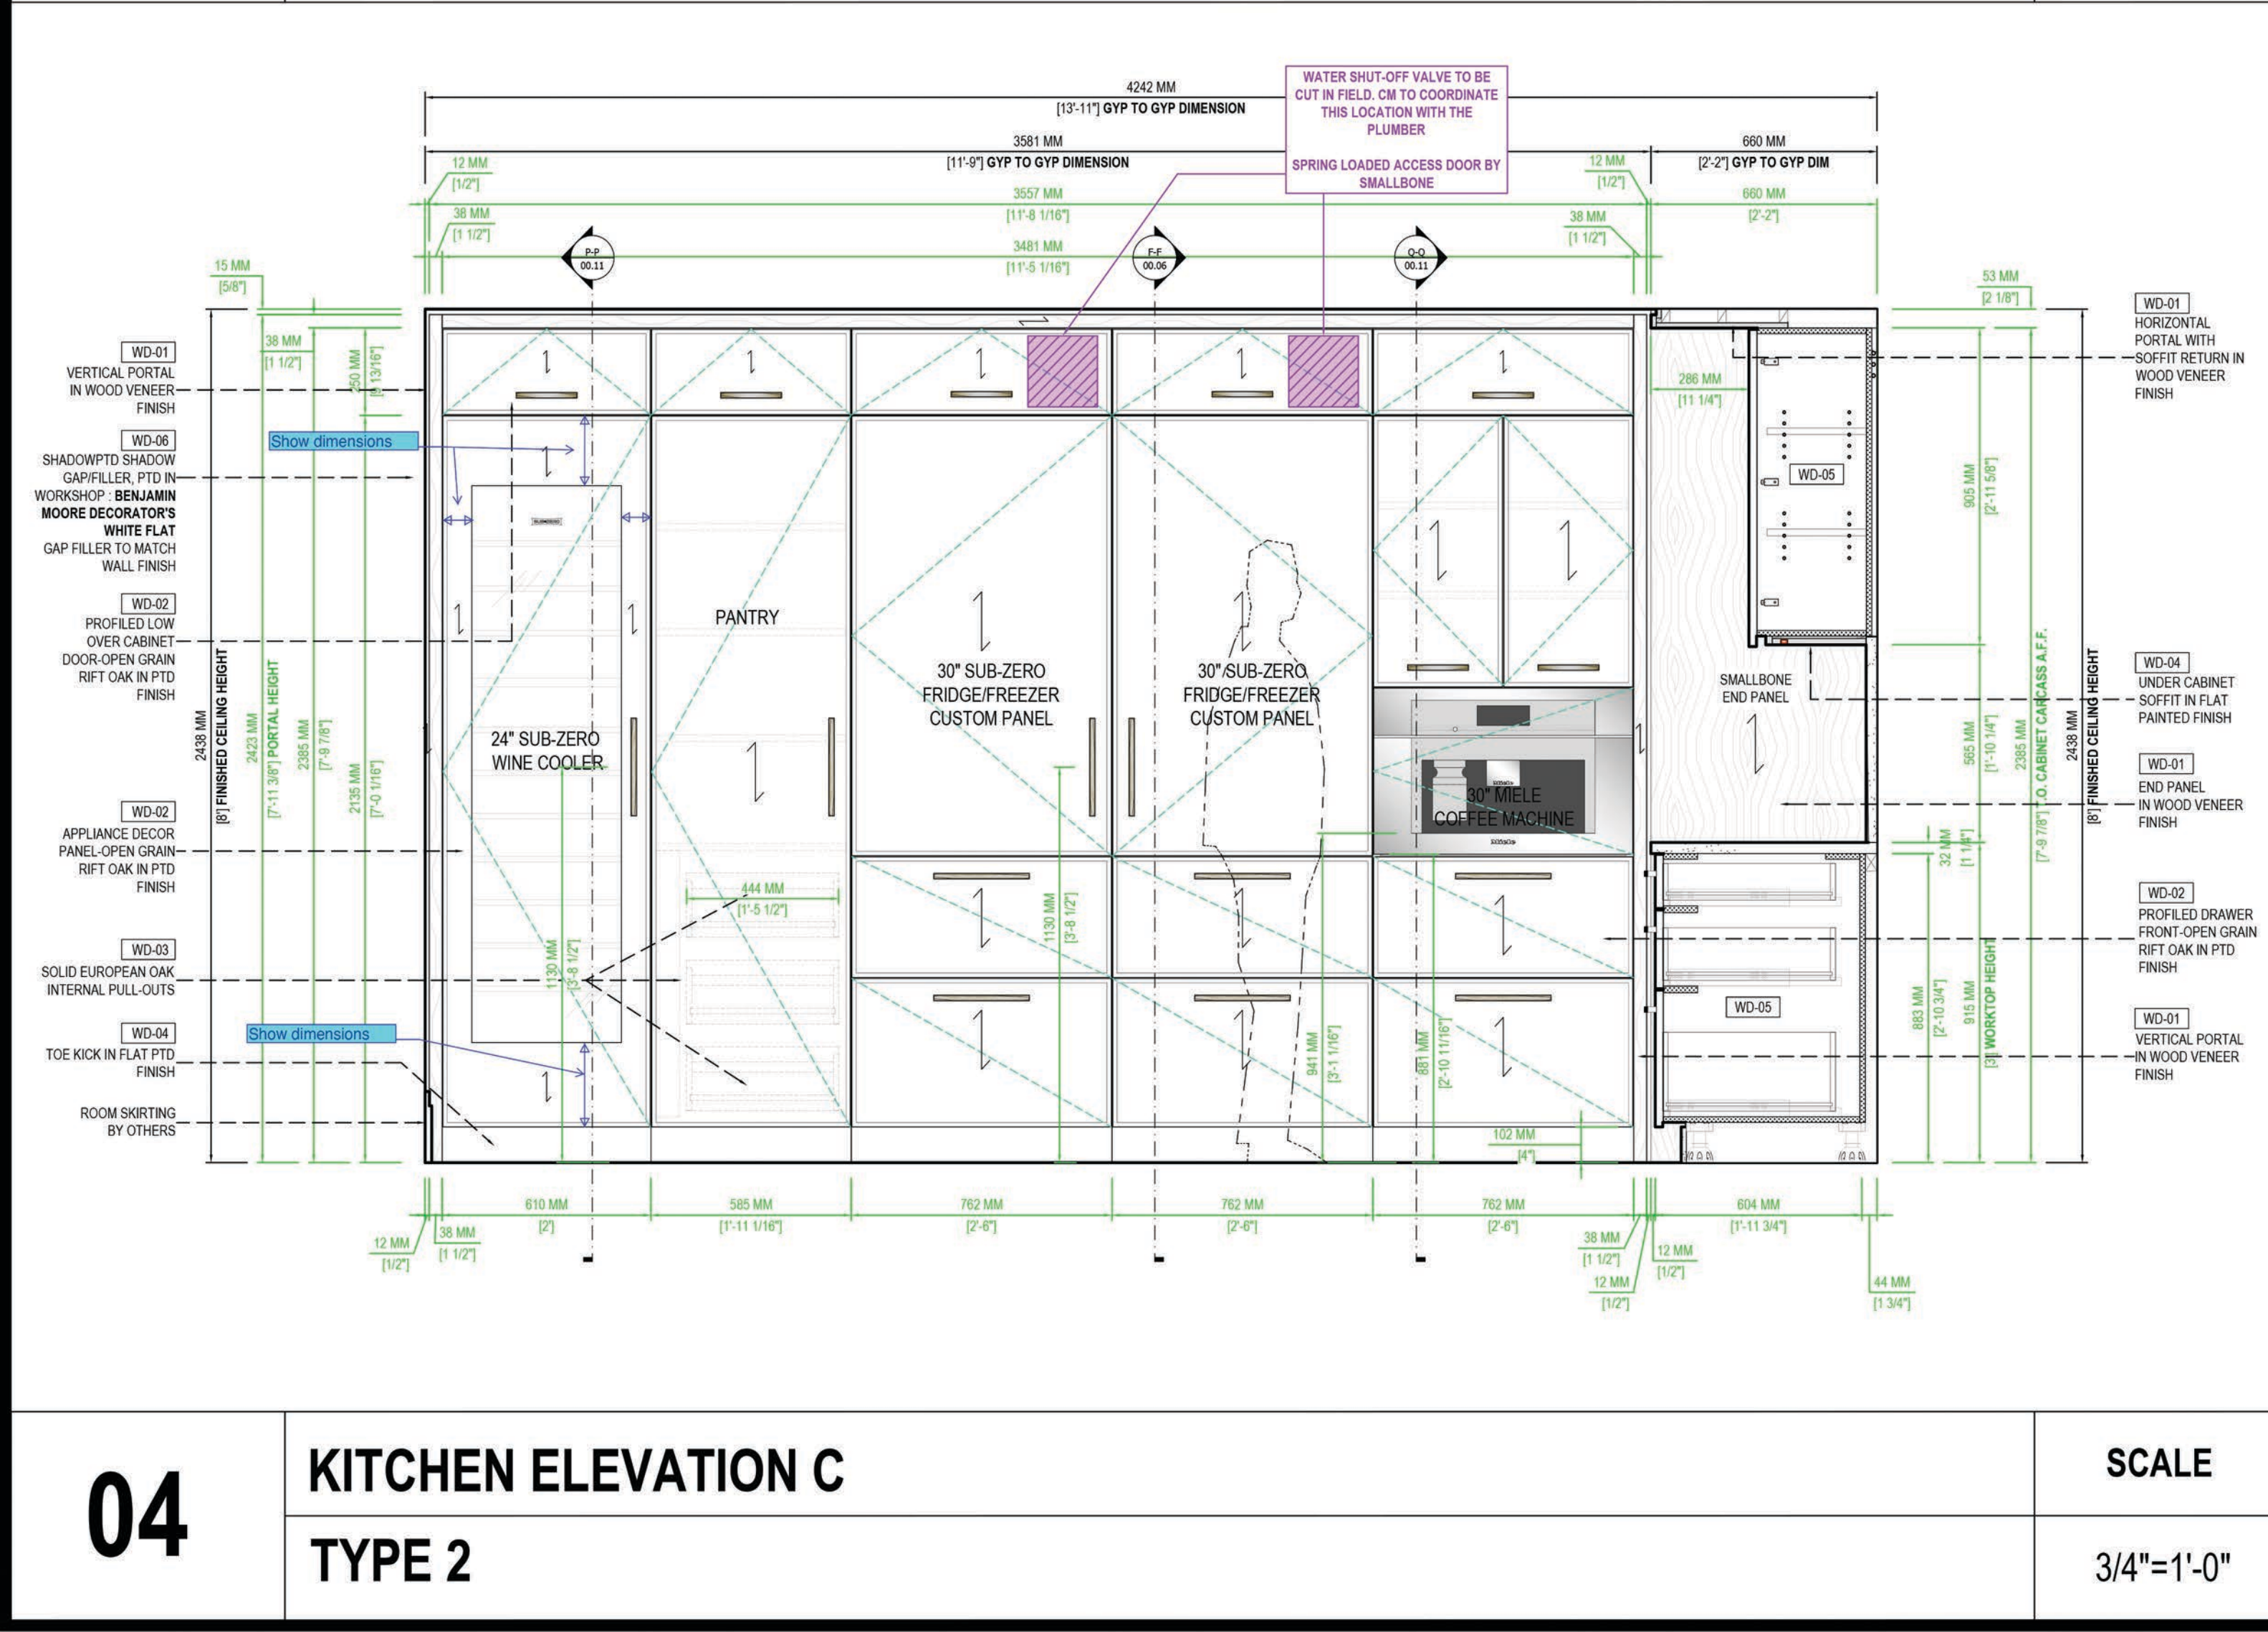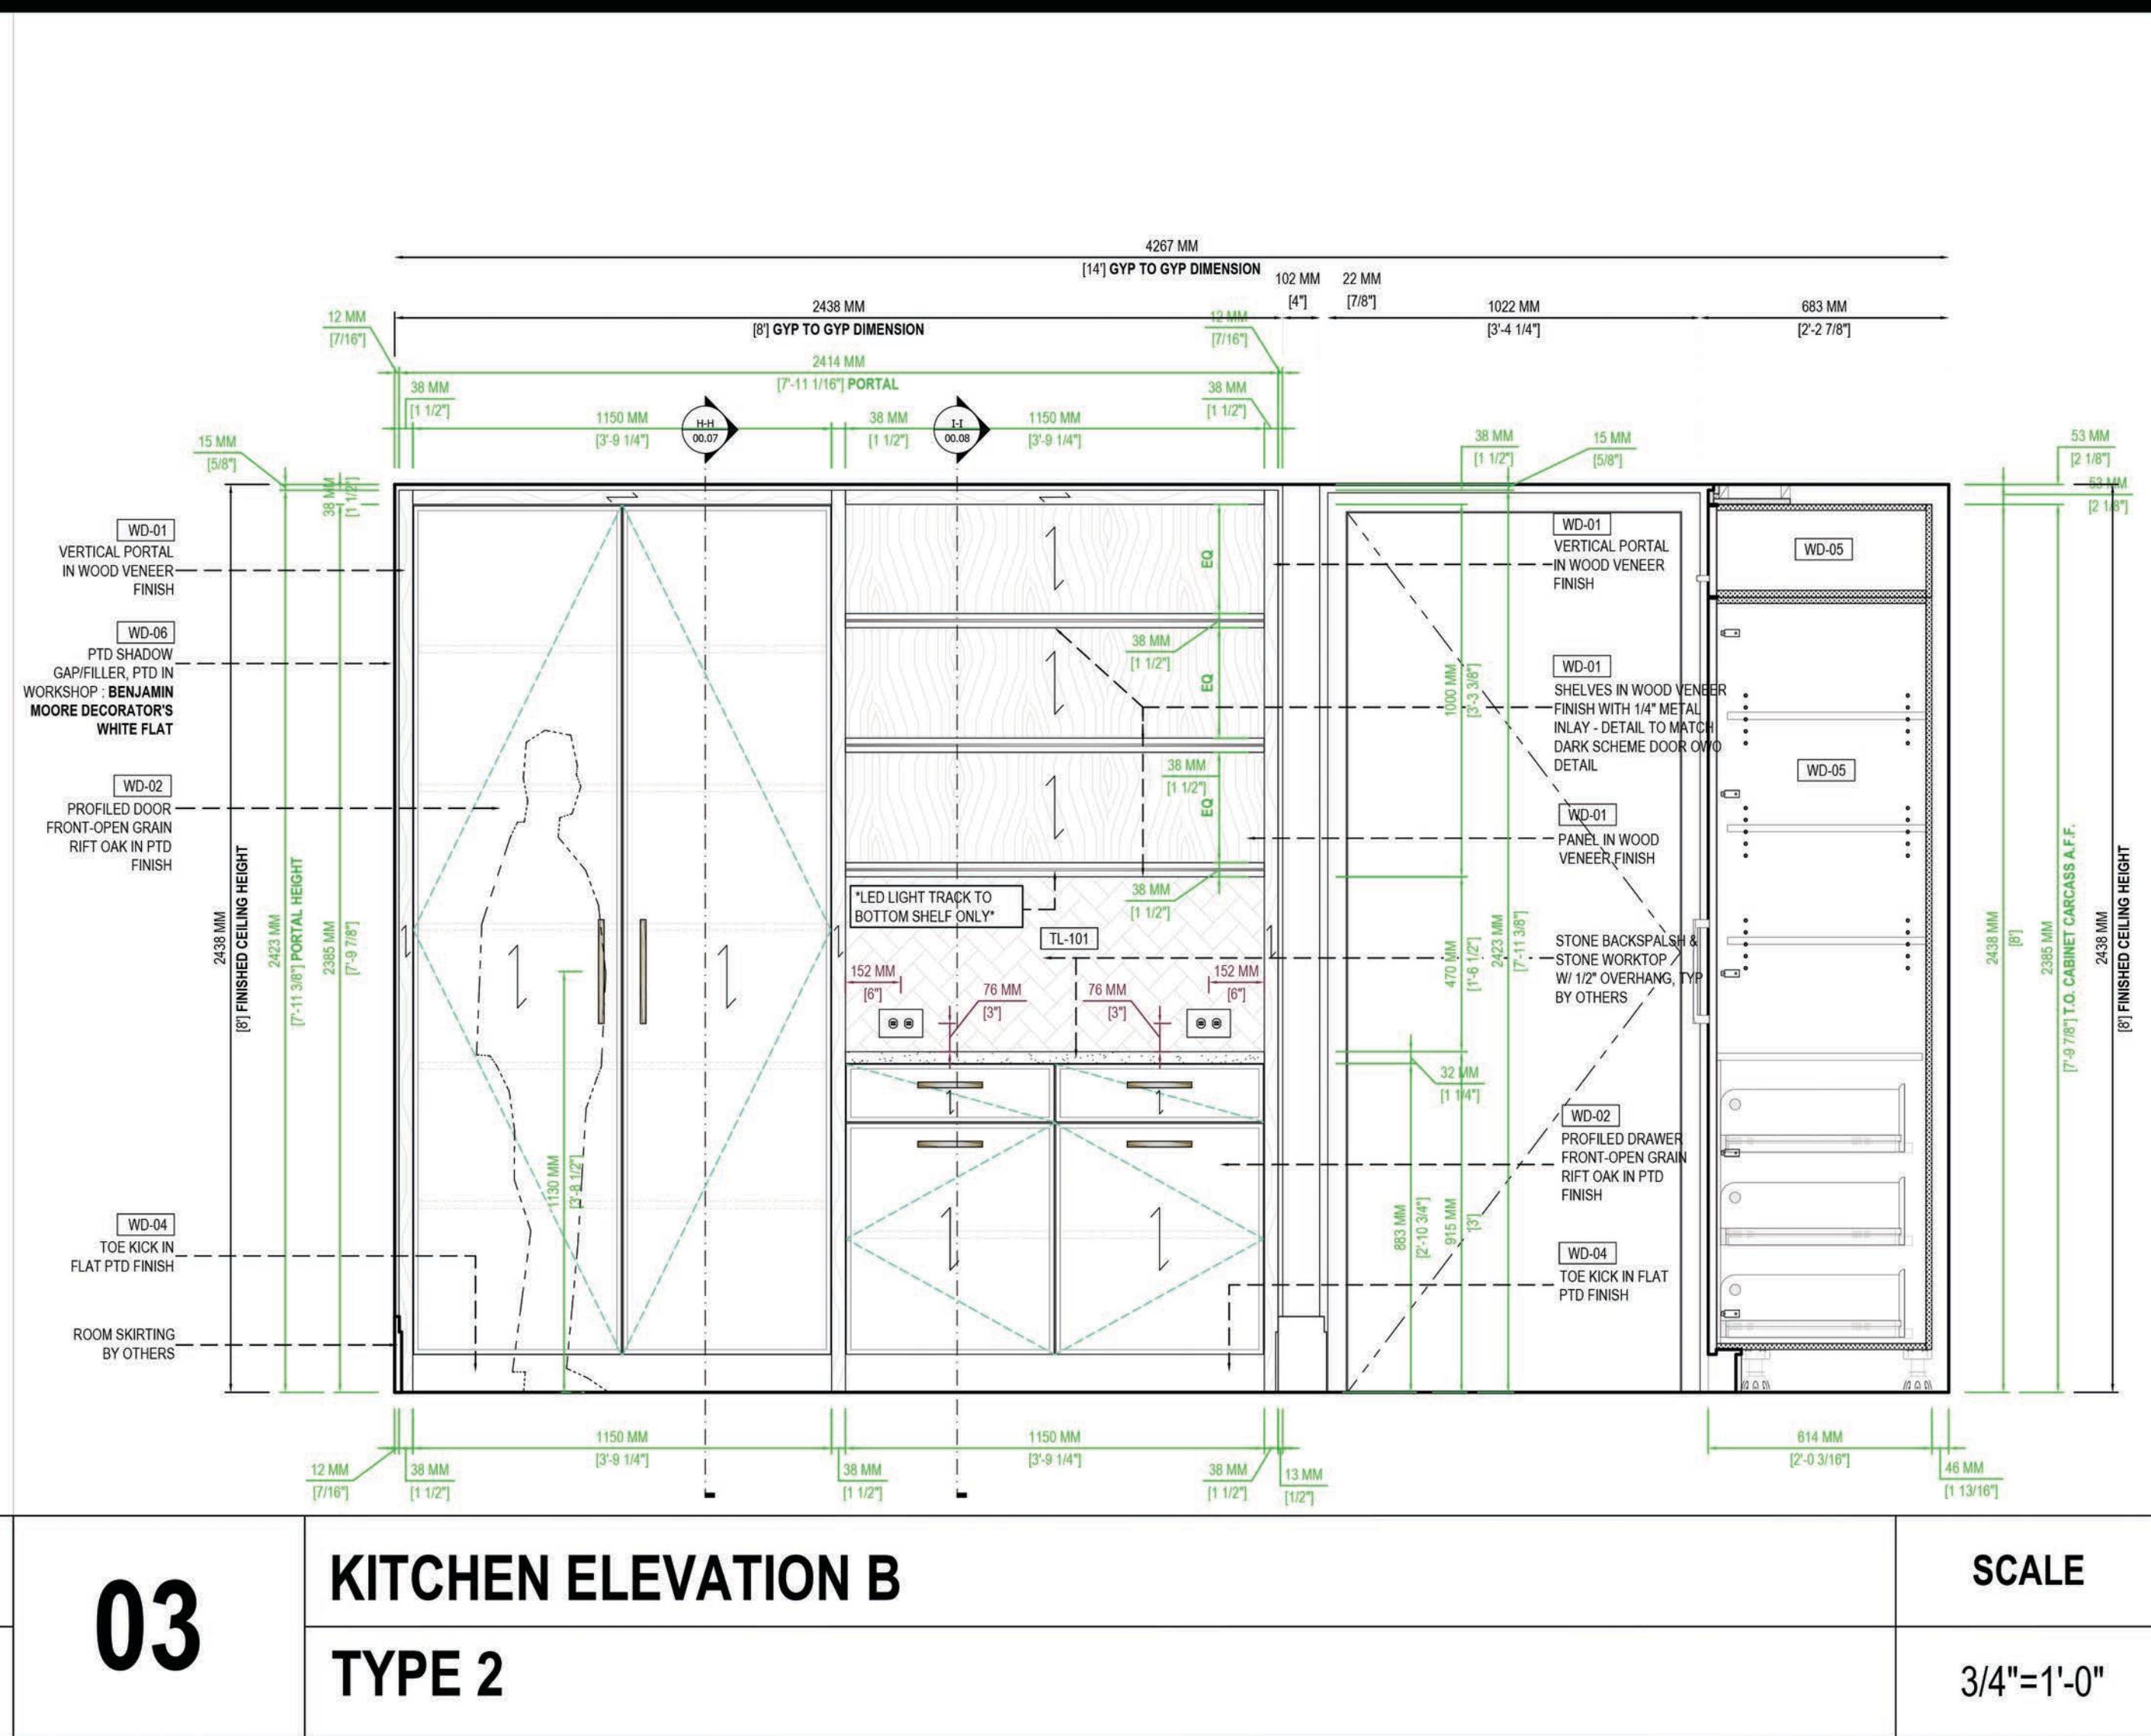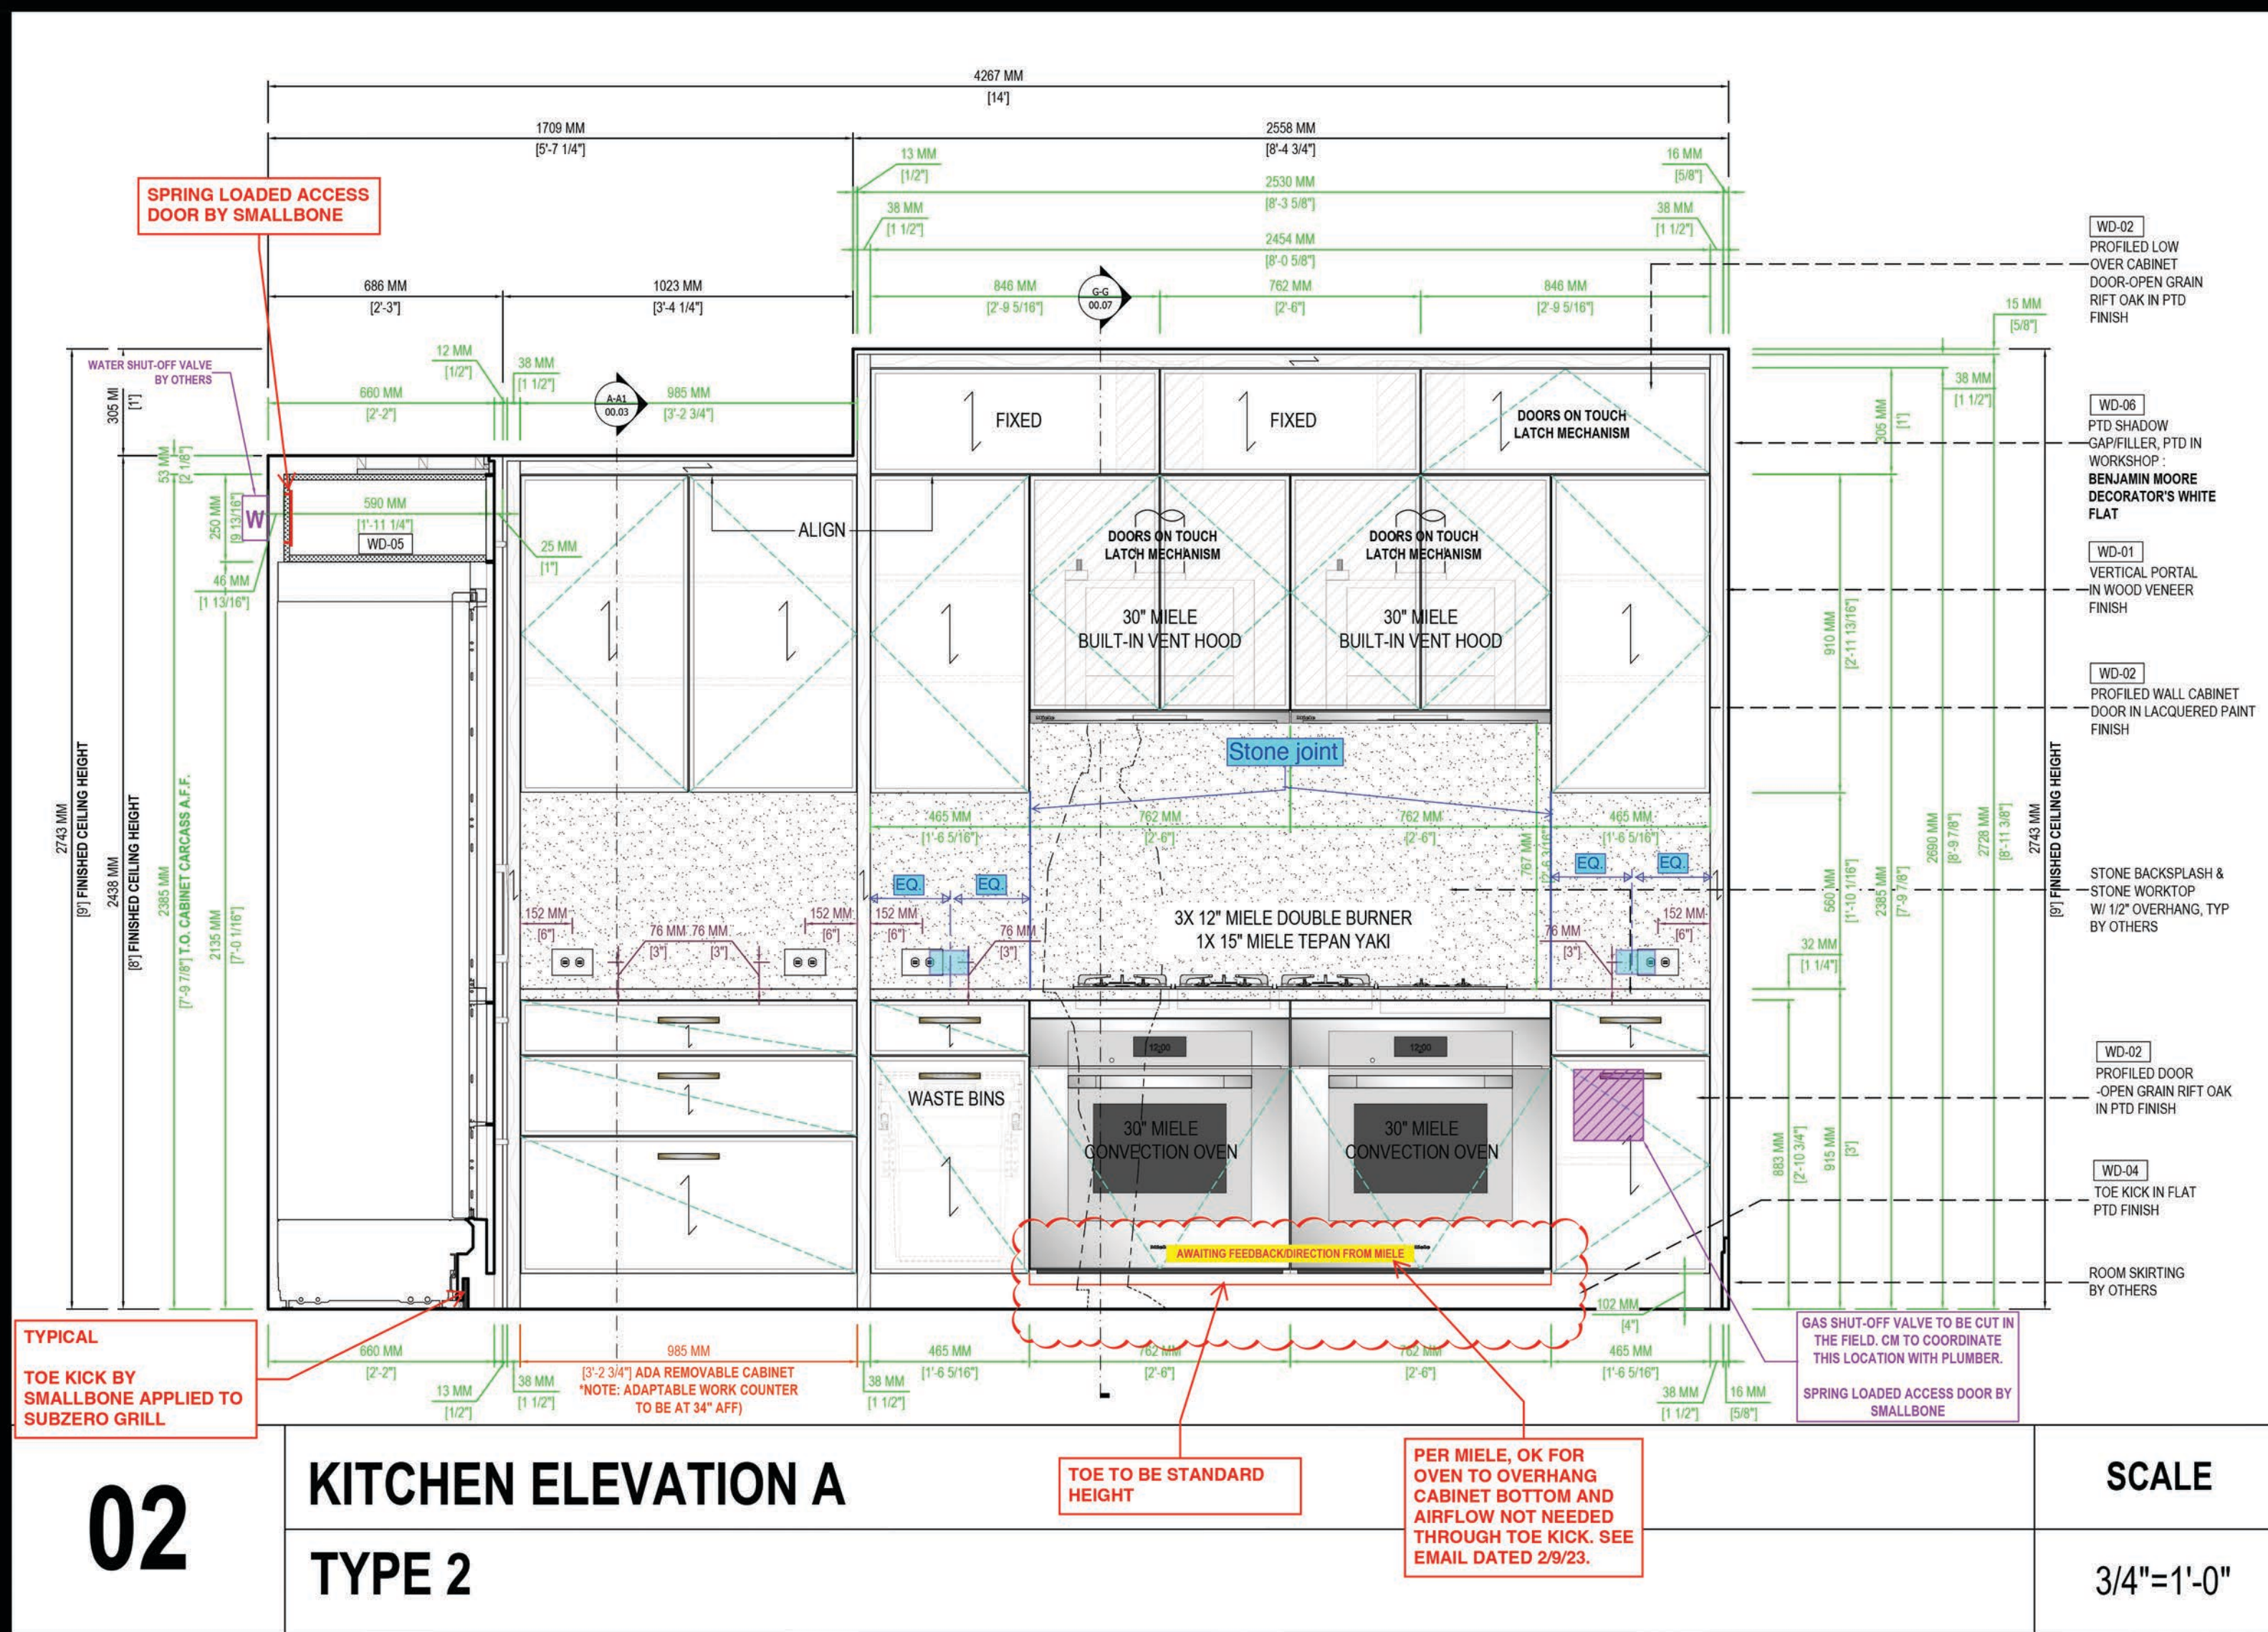

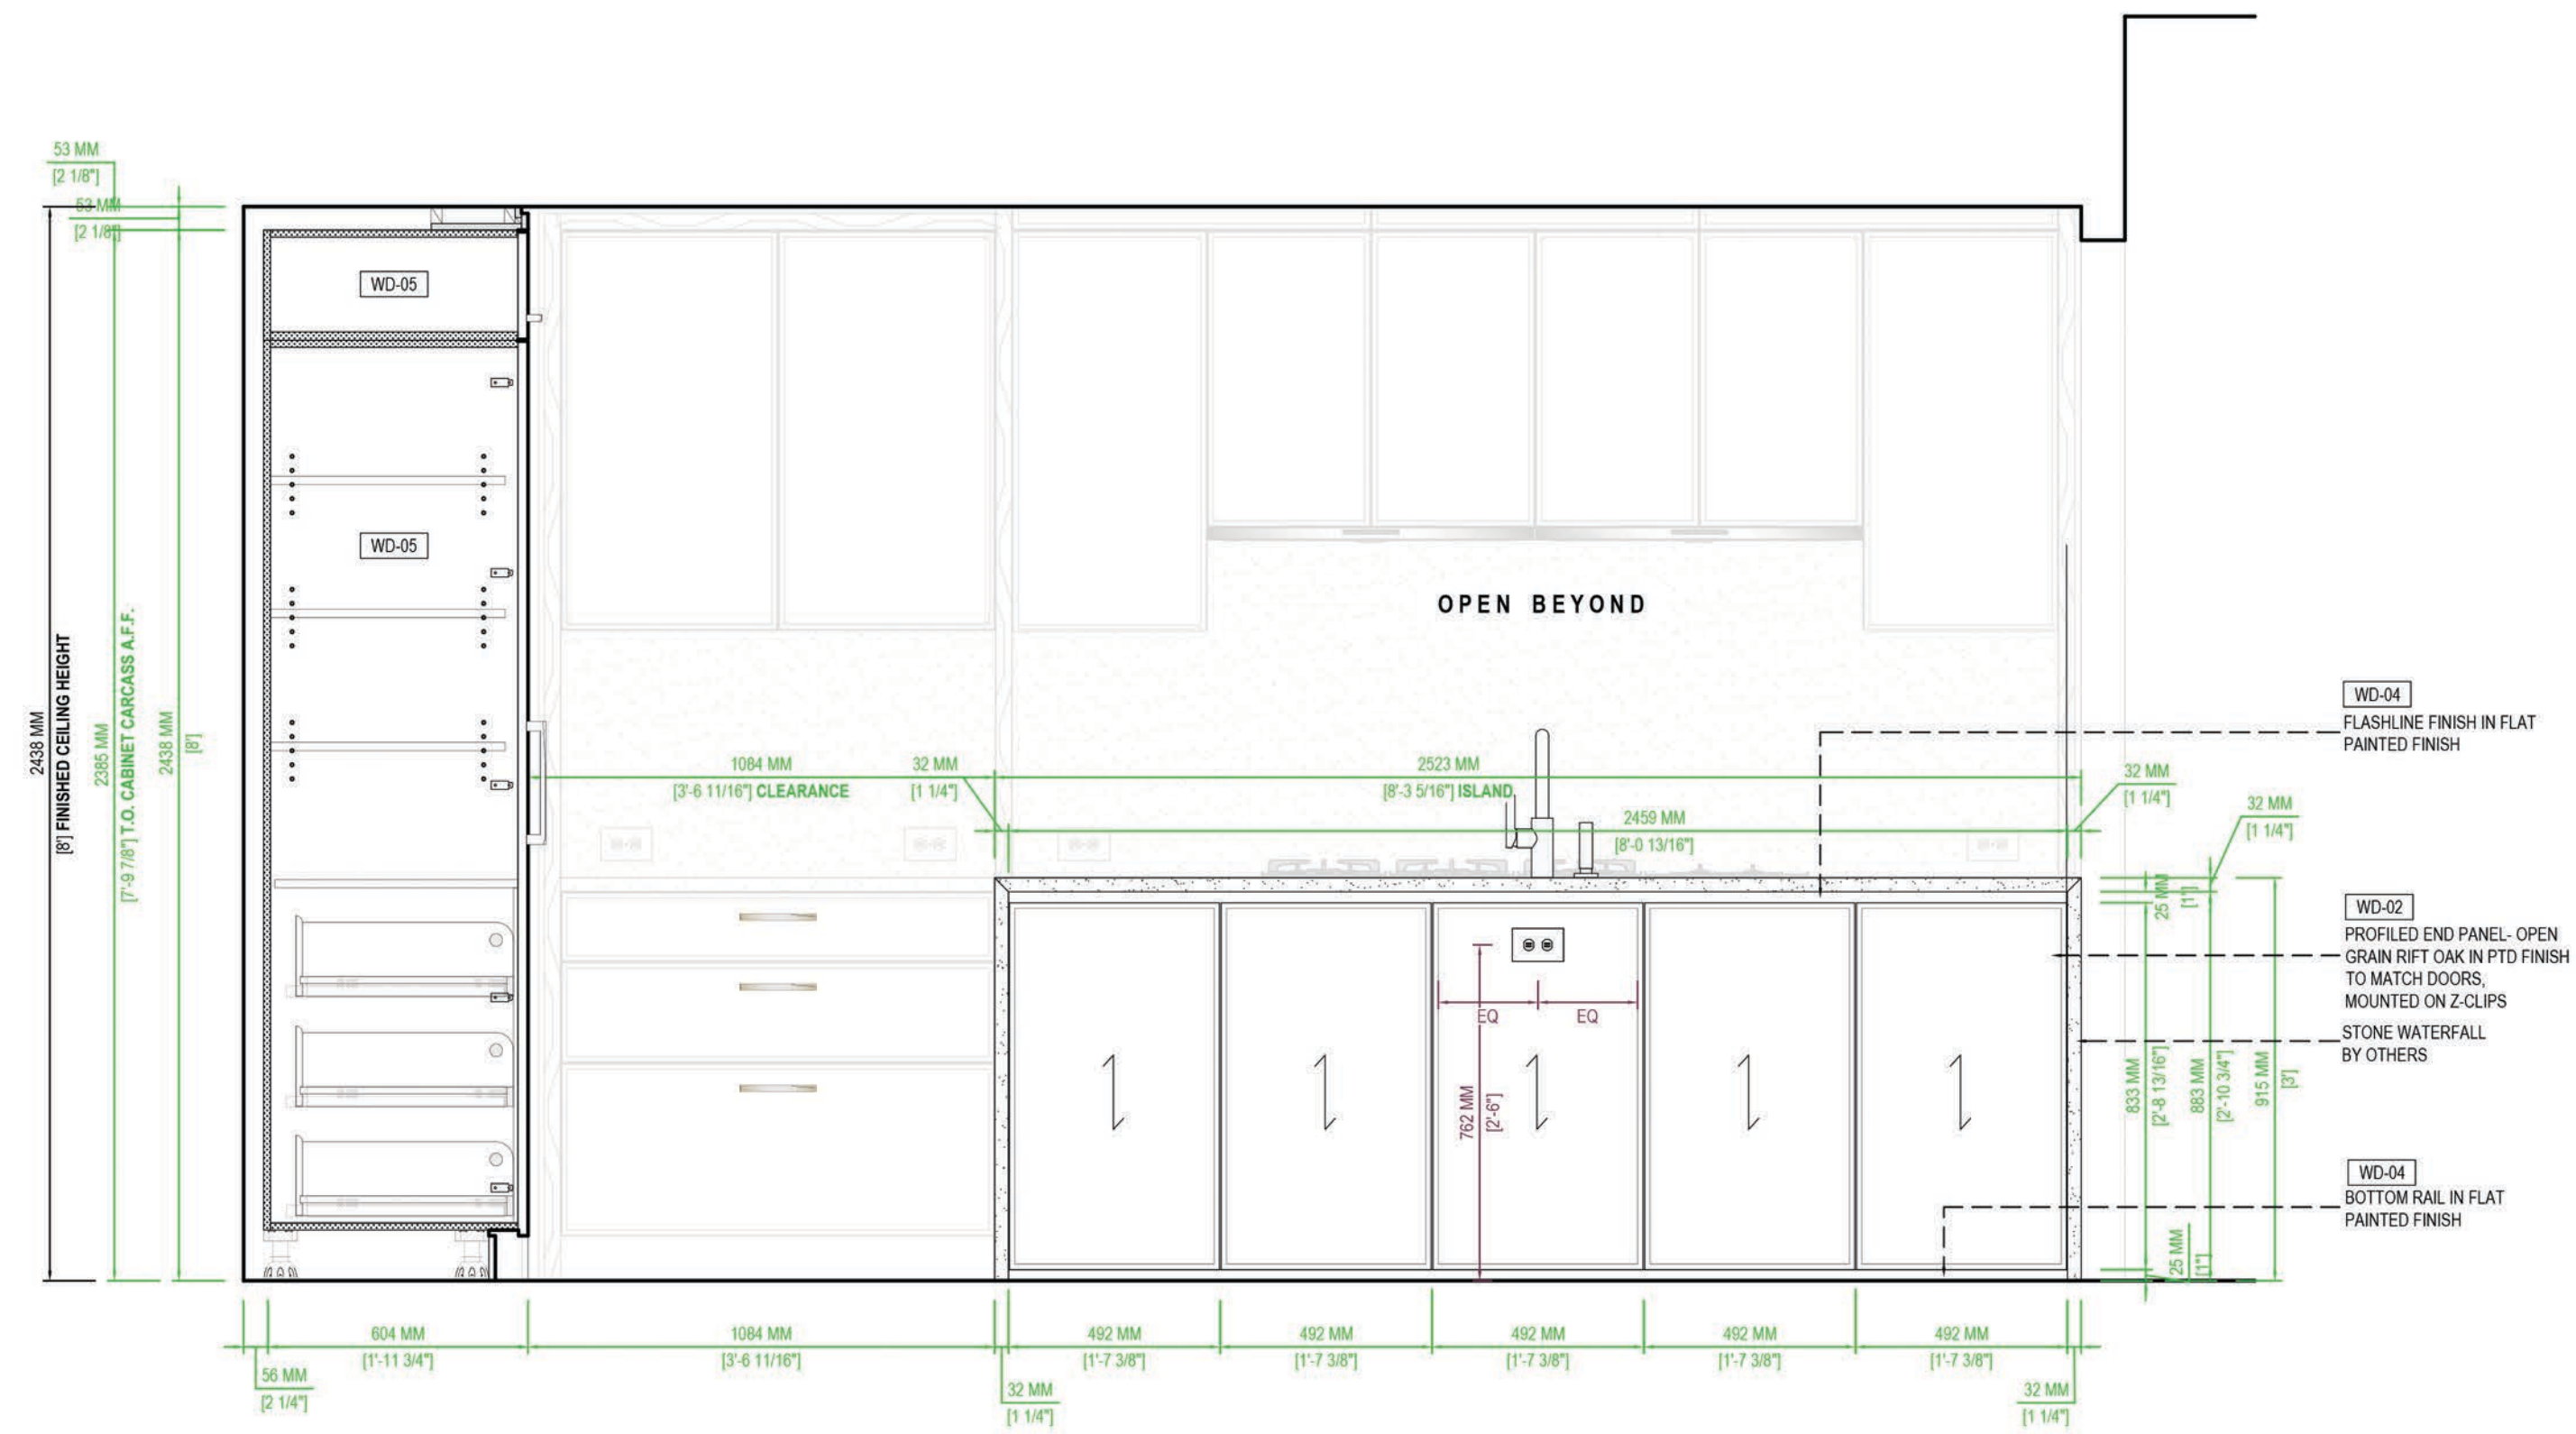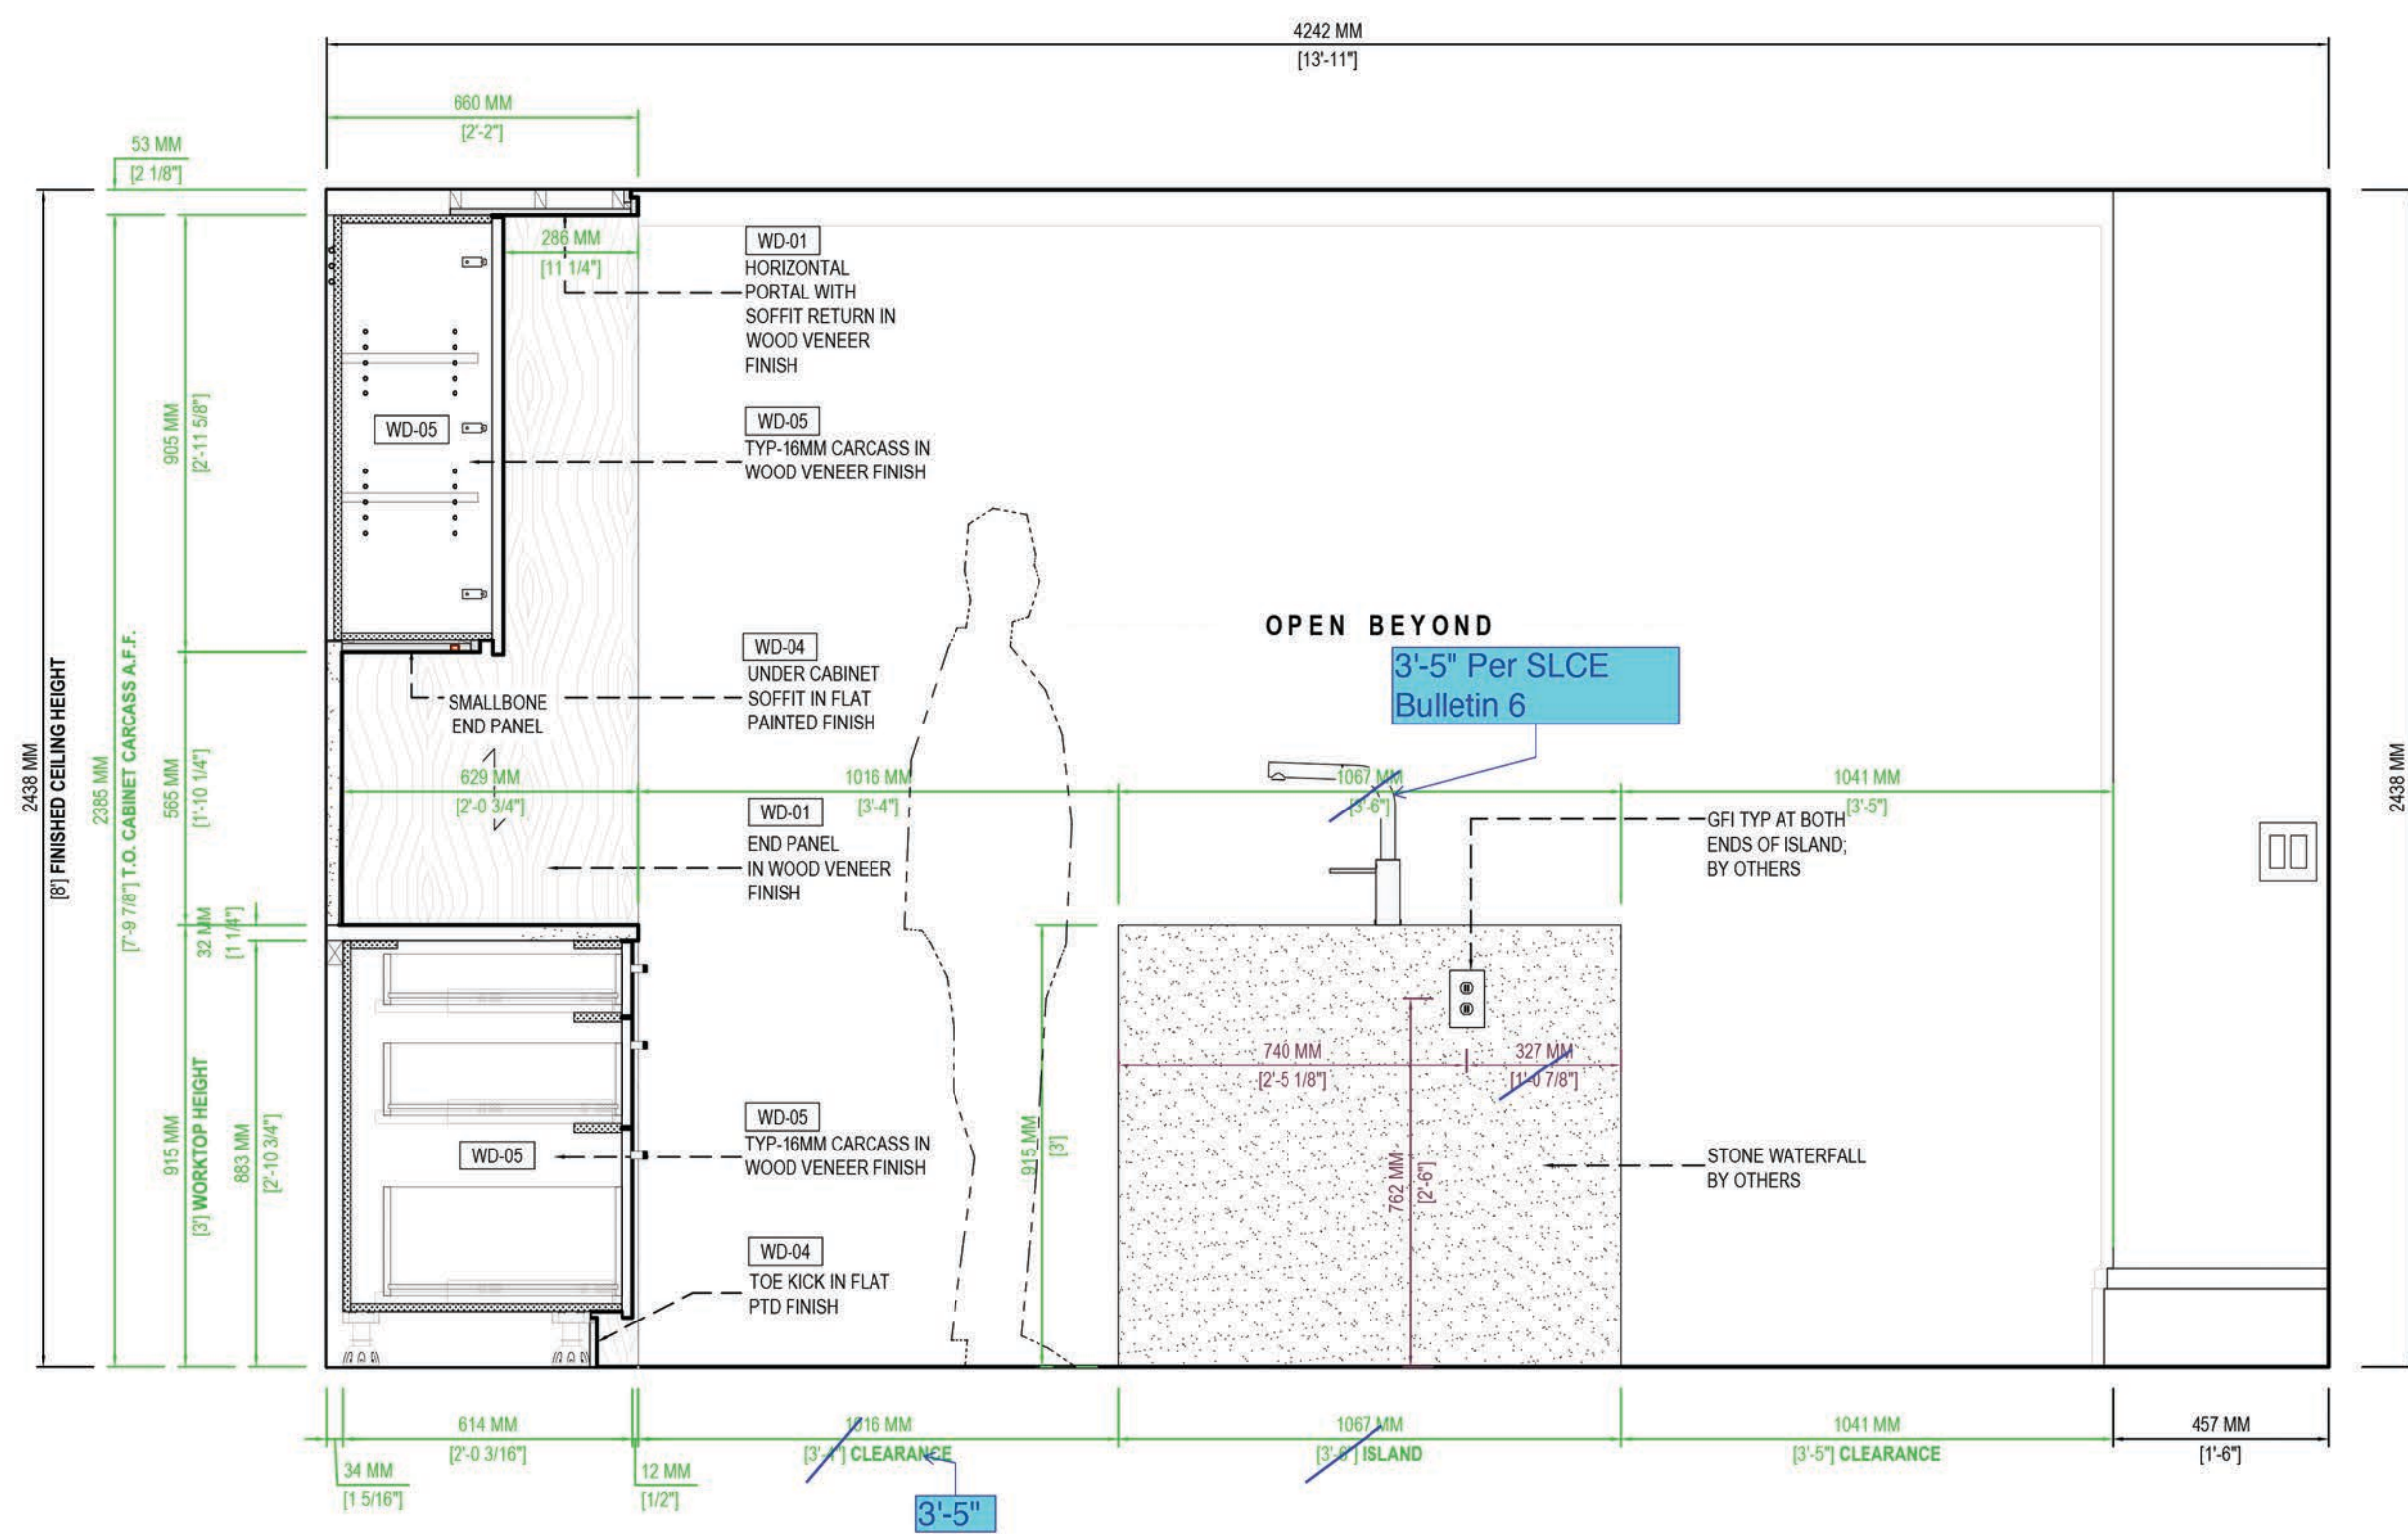

06

KITCHEN ELEVATION E

TYPE 2

SCALE

3/4"=1'-0'

07

KITCHEN ELEVATION F

TYPE 2

SCALE

3/4"=1'-0"